



PROPOSED STEWART'S SHOP

644-648 ROUTE 9
WILTON, NY 12831

SHEET NO.	DRAWING NAME	DESCRIPTION
1	T-1	TITLE SHEET
2	S-1	EXISTING SITE/DEMO PLAN
3	S-2	PROPOSED SITE PLAN
4	S-3	UTILITY PLAN
5	S-4	GRADING PLAN
6	S-5	LANDSCAPING PLAN
7	S-6	LIGHTING PLAN
8	S-7	STORMWATER DETAILS
9	S-8	EROSION & SEDIMENT CONTROL PLAN
10	S-9	TRUCK CIRCULATION PLAN
11	S-10	MISCELLANEOUS DETAILS
12	S-11	MISCELLANEOUS DETAILS
13	S-12	MISCELLANEOUS DETAILS
14	S-13	MISCELLANEOUS DETAILS
15	S-14	MISCELLANEOUS DETAILS
16	S-15	MISCELLANEOUS DETAILS

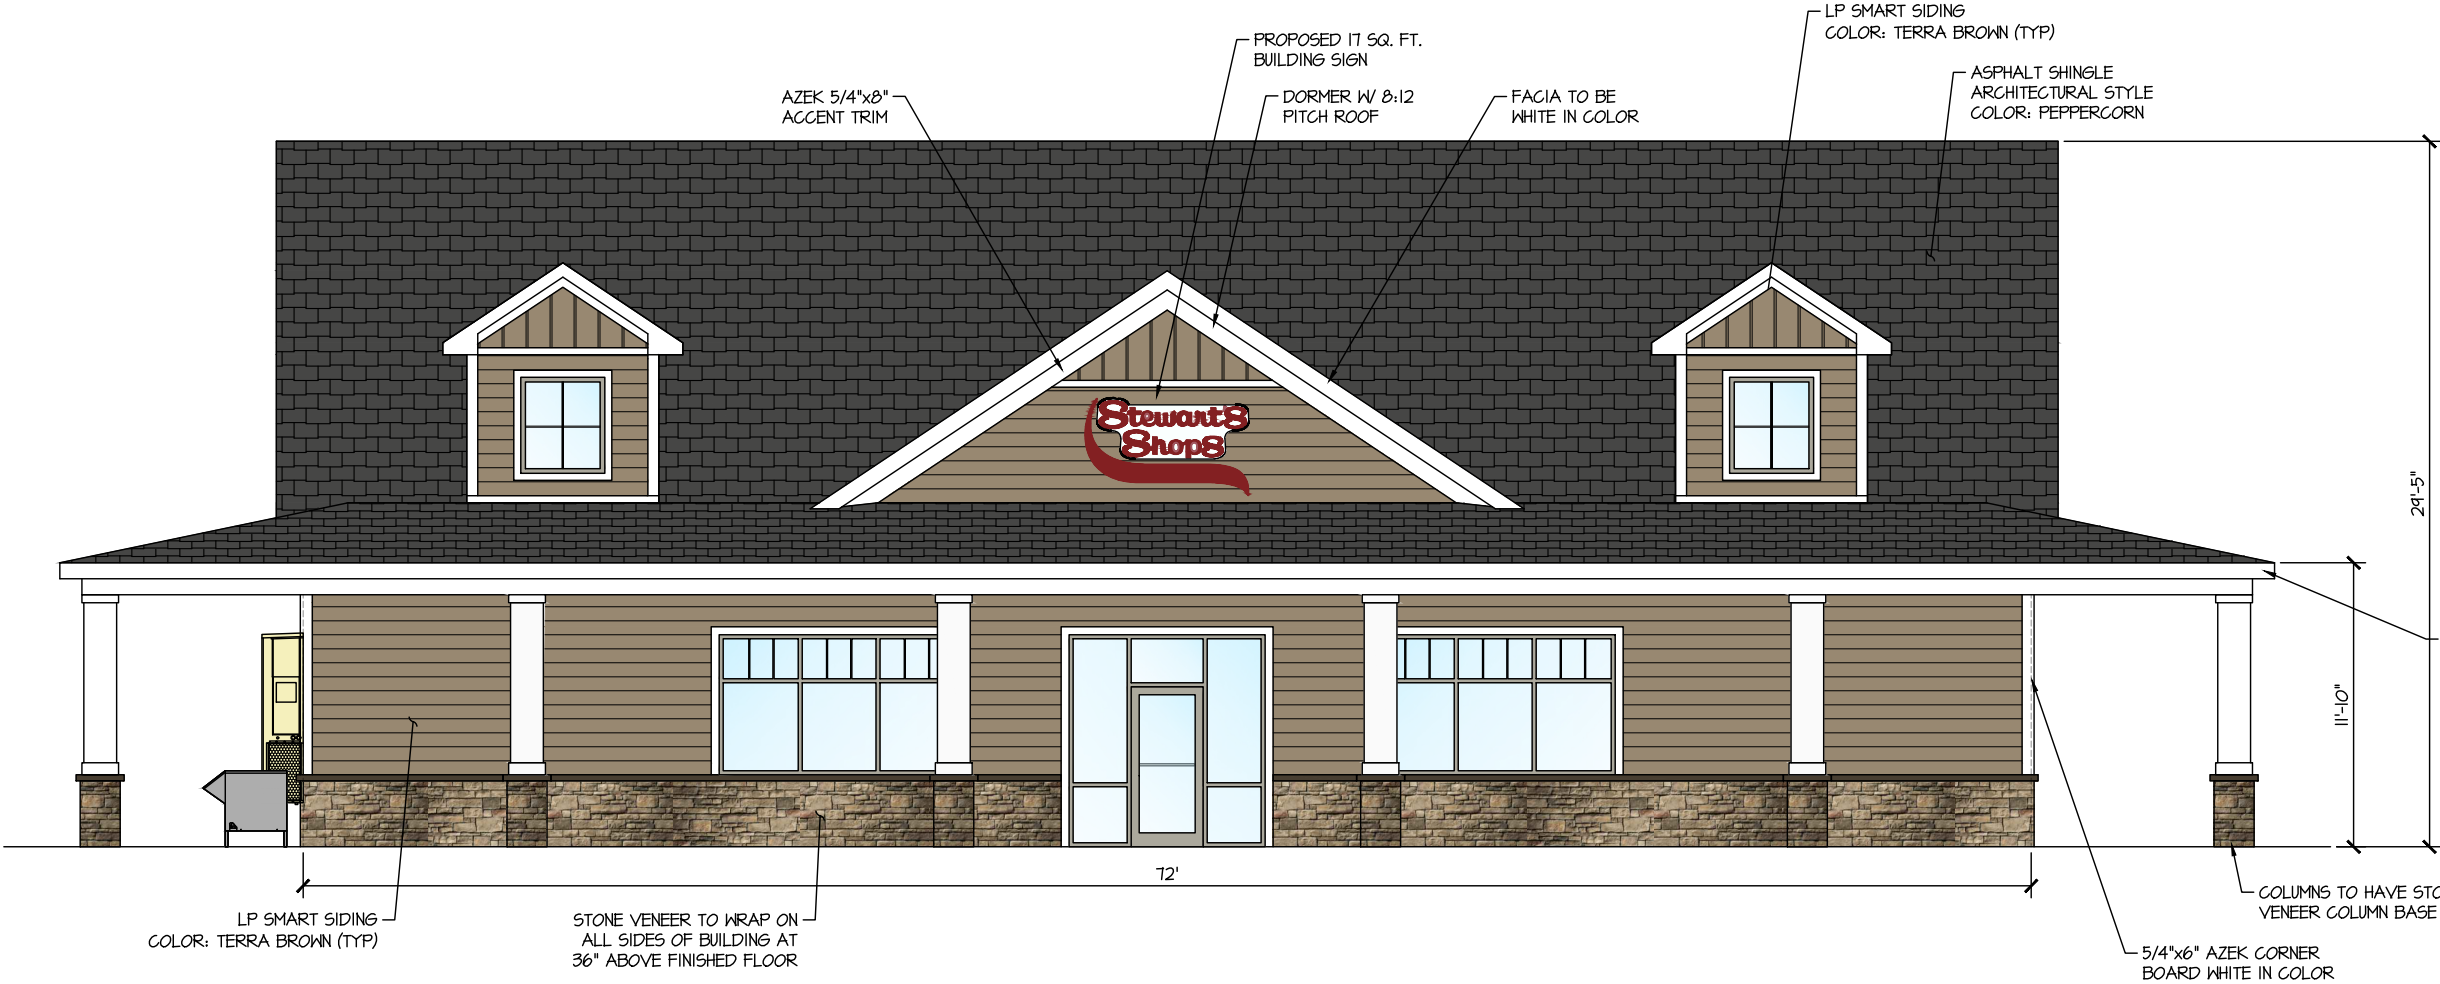


WEST BUILDING ELEVATION

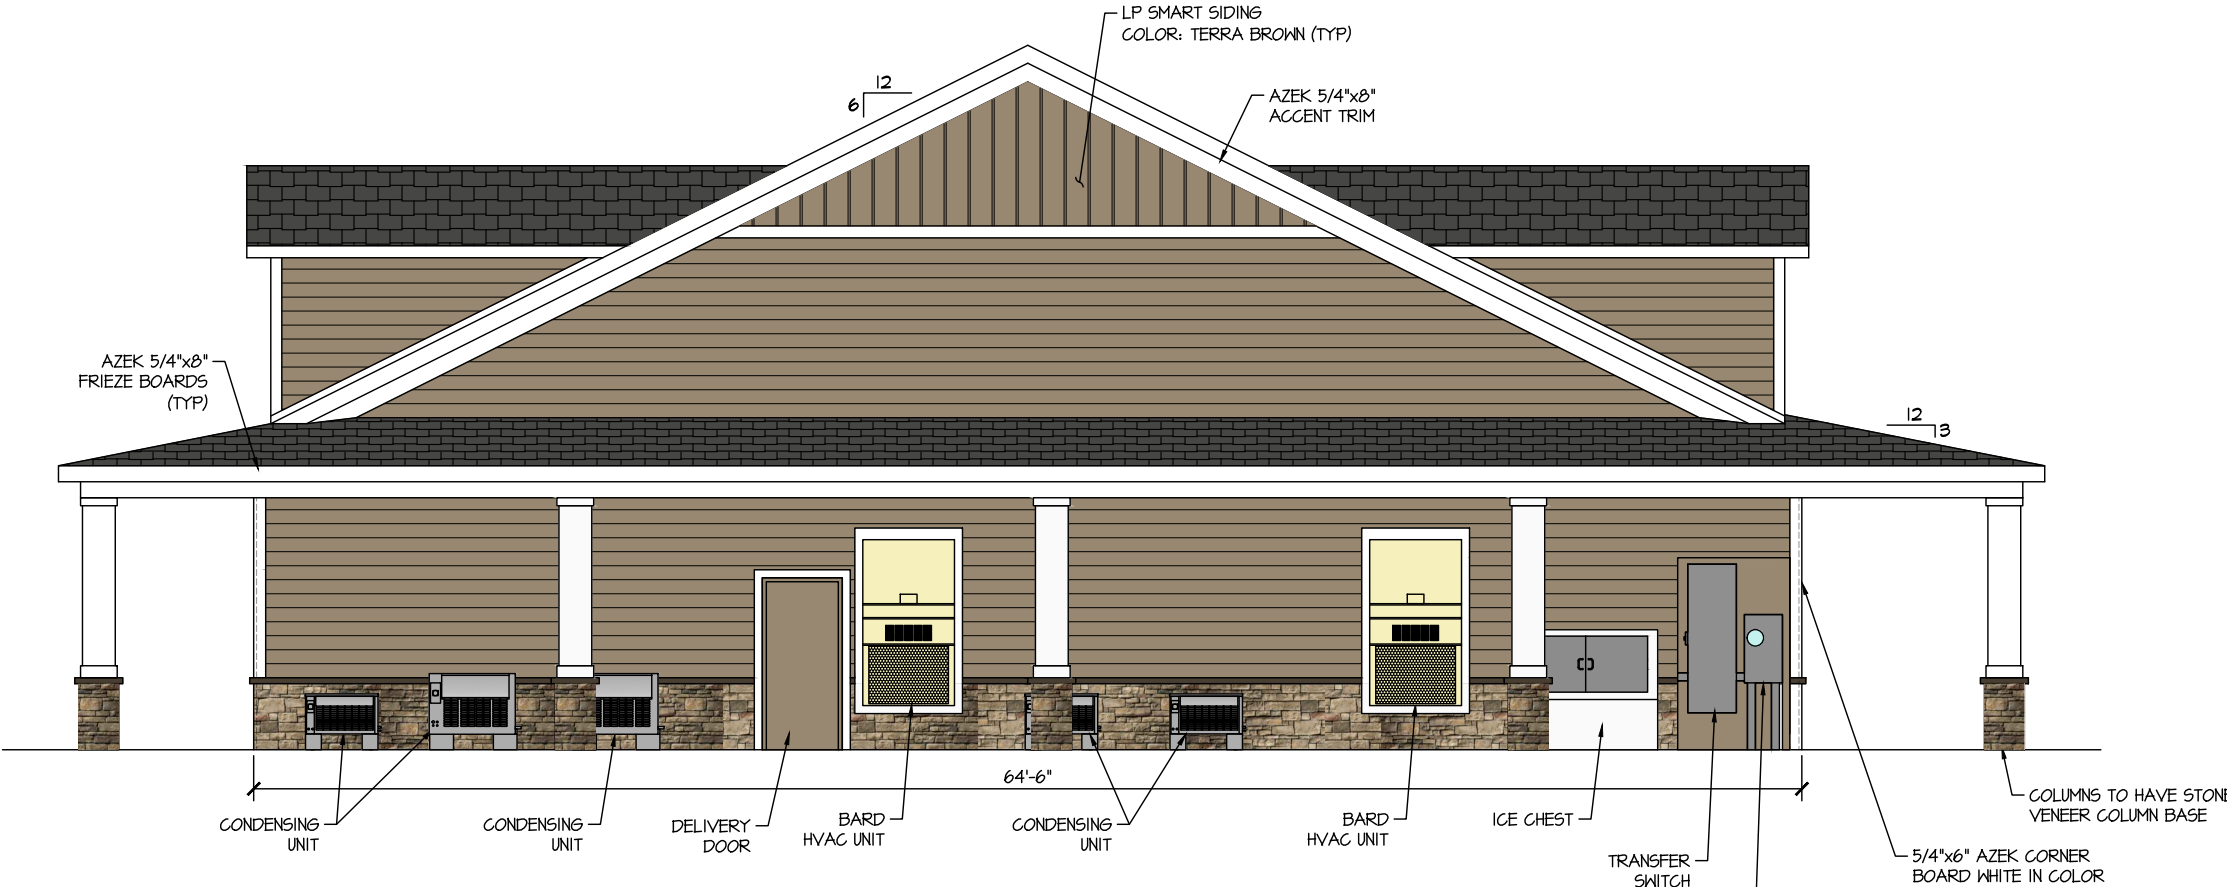


NORTH BUILDING ELEVATION




SOUTH BUILDING ELEVATION

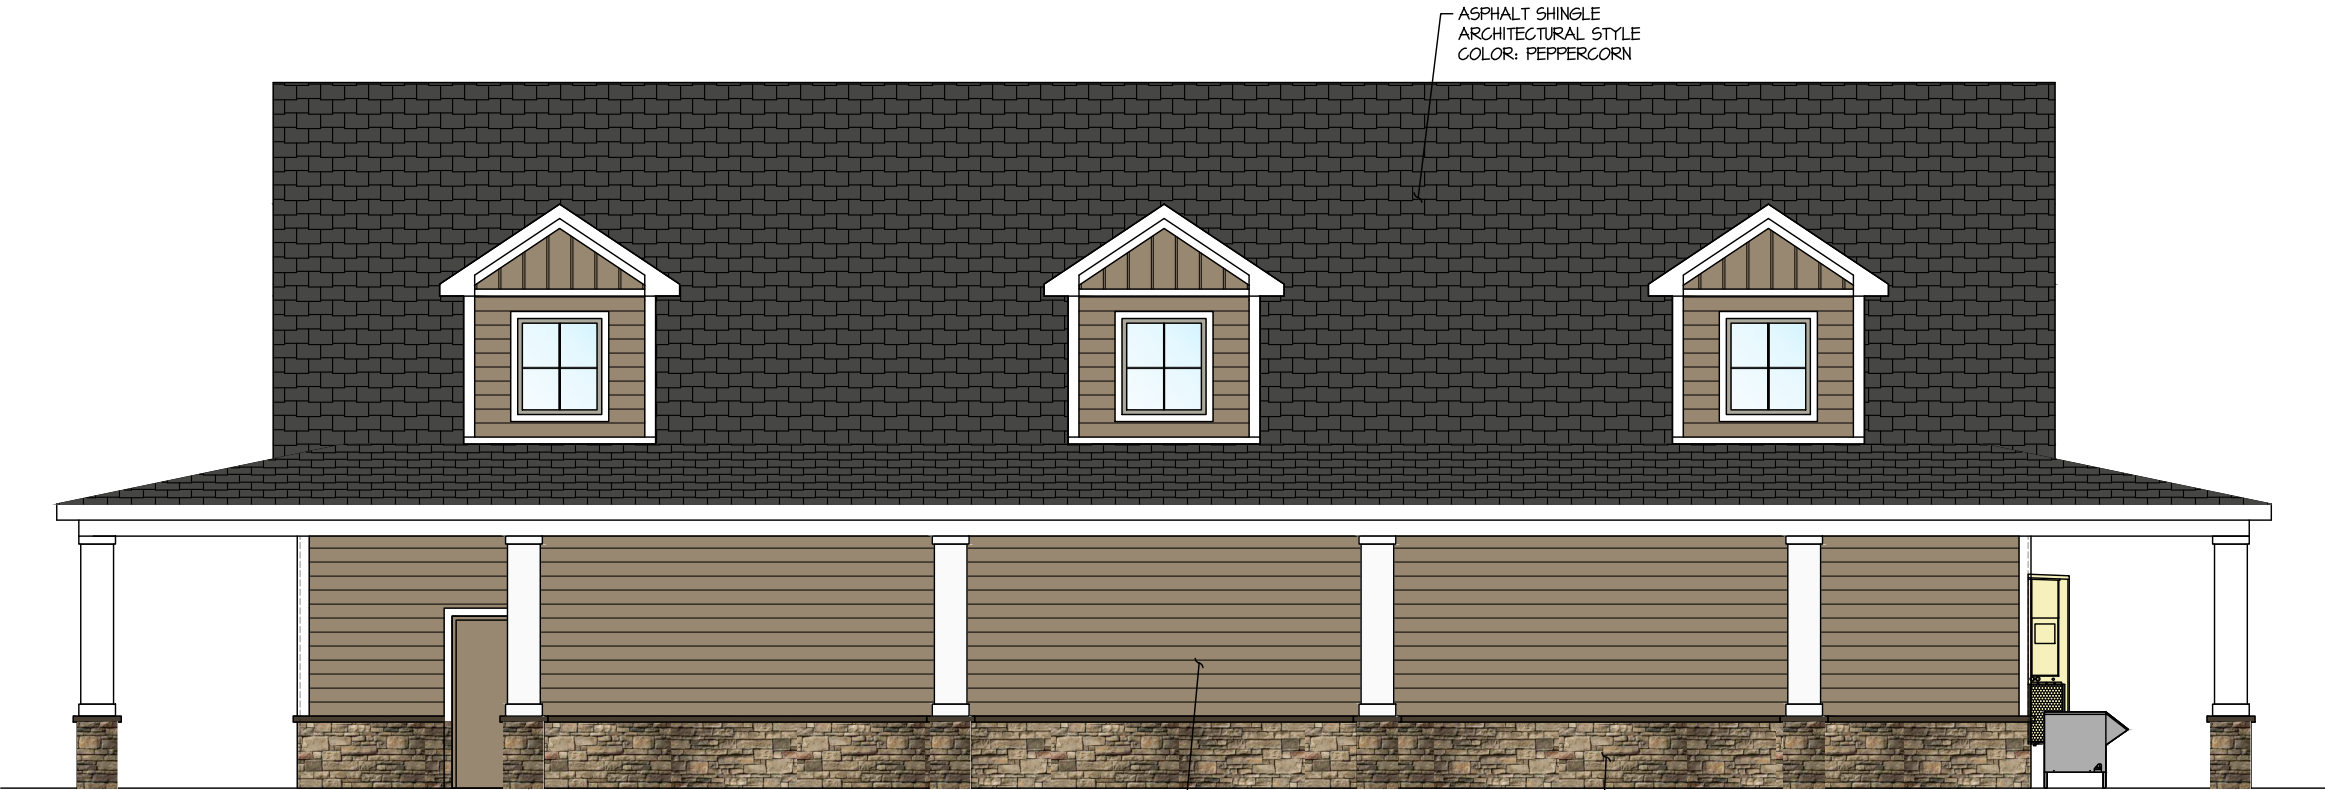

EAST BUILDING ELEVATION

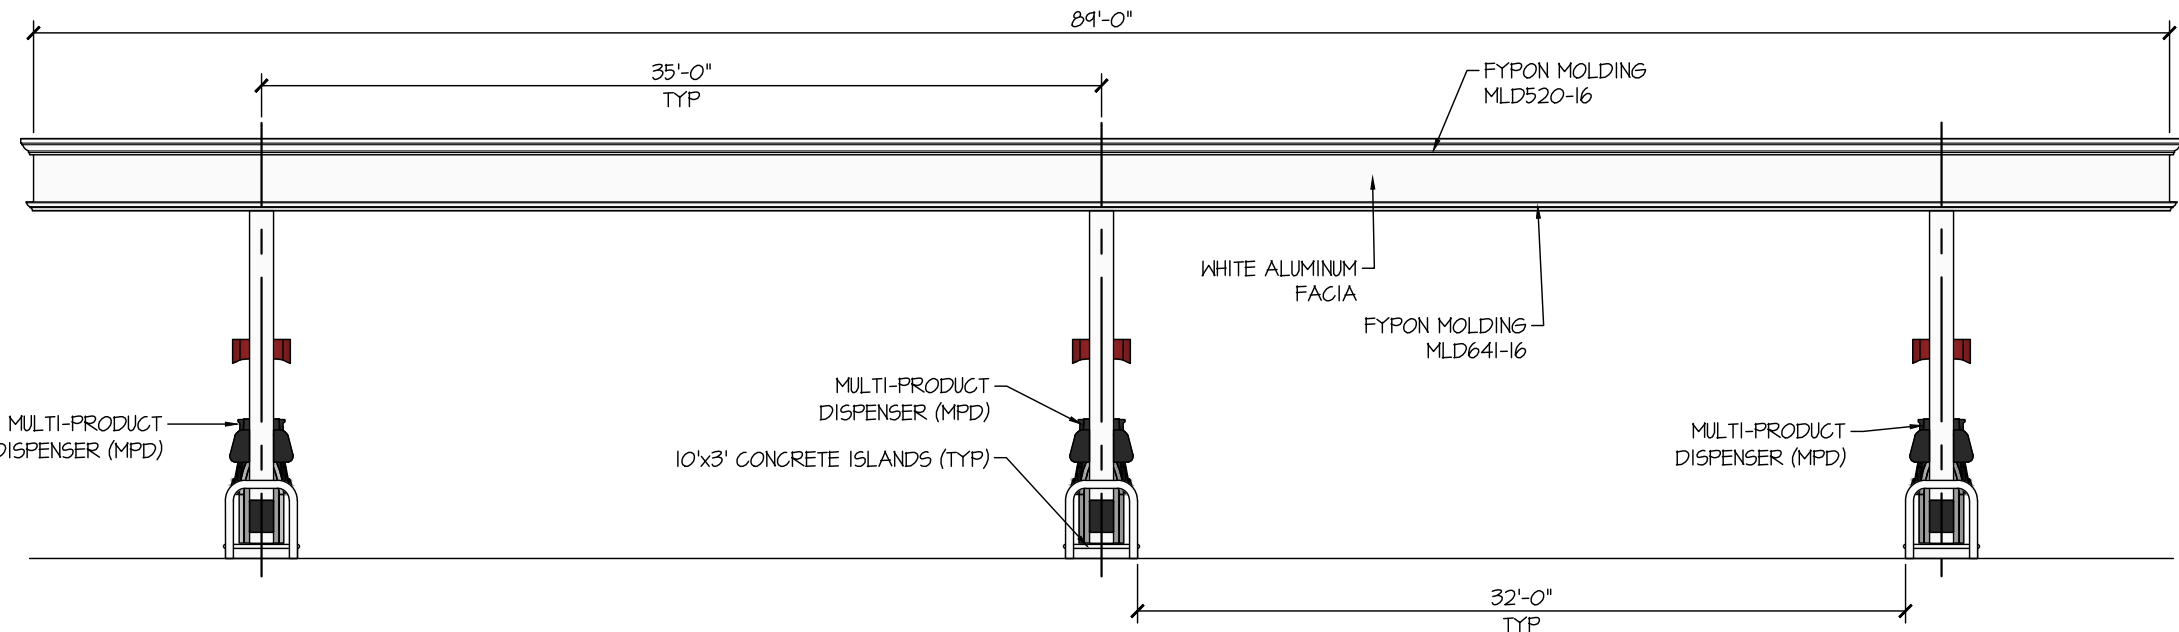

GAS CANOPY NORTH ELEVATION

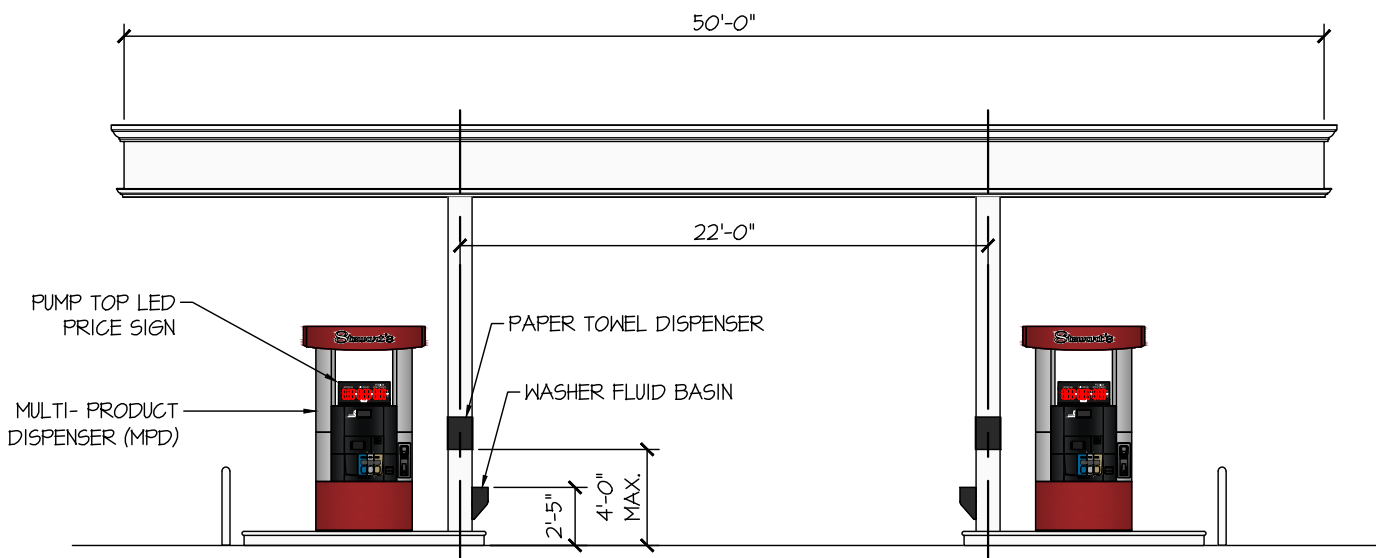

GAS CANOPY WEST ELEVATION



TYPICAL BUILDING SIGN

- SIZE: - 17 SQ. FT.
LETTERS: - 1/8" PLEXIGLASS FACE ON 4-1/2" THICK CAN
ILLUMINATION: - EXTERNALLY ILLUMINATED WITH LED GOOSENECK LIGHTING
- BURGUNDY LETTERS
- WHITE COLOR BACKGROUND



PROPOSED MONUMENT SIGN

- SIZE: - 5'-0"x7'-0" = 35 SQ. FT.
LETTERS: - 1/8" PLEXIGLASS FACE ON 4-1/2" THICK CAN
ILLUMINATION: - INTERNALLY ILLUMINATED WITH LED LIGHTING
- BURGUNDY LETTERS
- WHITE COLOR BACKGROUND
- 12" RED LED GAS PRICE NUMBERS
- 12" GREEN LED DIESEL PRICE NUMBERS

	STORE NAME, ABBREVIATION & NO. DAVIDSON DRIVE - DAVQ - 444		
	SITE LOCATION 644-648 ROUTE 9 - WILTON, NY 12831		
	DATE	NO. REVISIONS	
	DRAWN BY: CP SCALE: AS SHOWN DATE: 1/4/26 DRAWING NO. T-1		
ALTERATIONS TO THIS DOCUMENT BY OTHER THAN AN AUTHORIZED LICENSED PROFESSIONAL ENGINEER IS ILLEGAL AND A VIOLATION OF THE NEW YORK STATE EDUCATION LAW		SARATOGA SPRINGS, NY 12866 TEL. (518)581-1200 FAX (518)581-1209	
TITLE: TITLE SHEET			